



PLANTA BAIXA

ESCALA 1:100

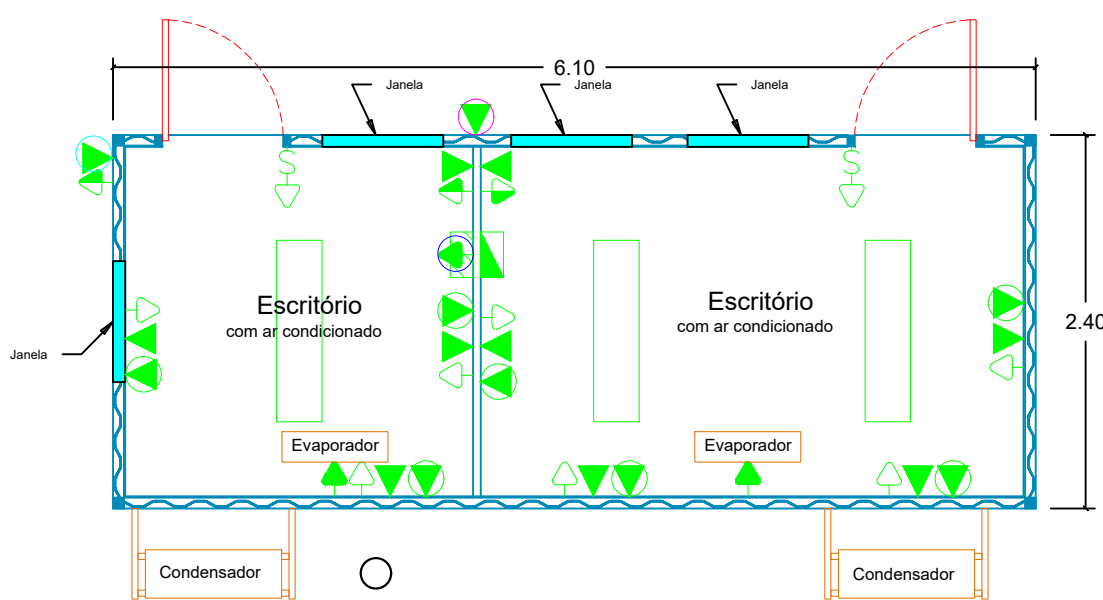


PLANTA BAIXA (Escritório)

ESCALA 1:50

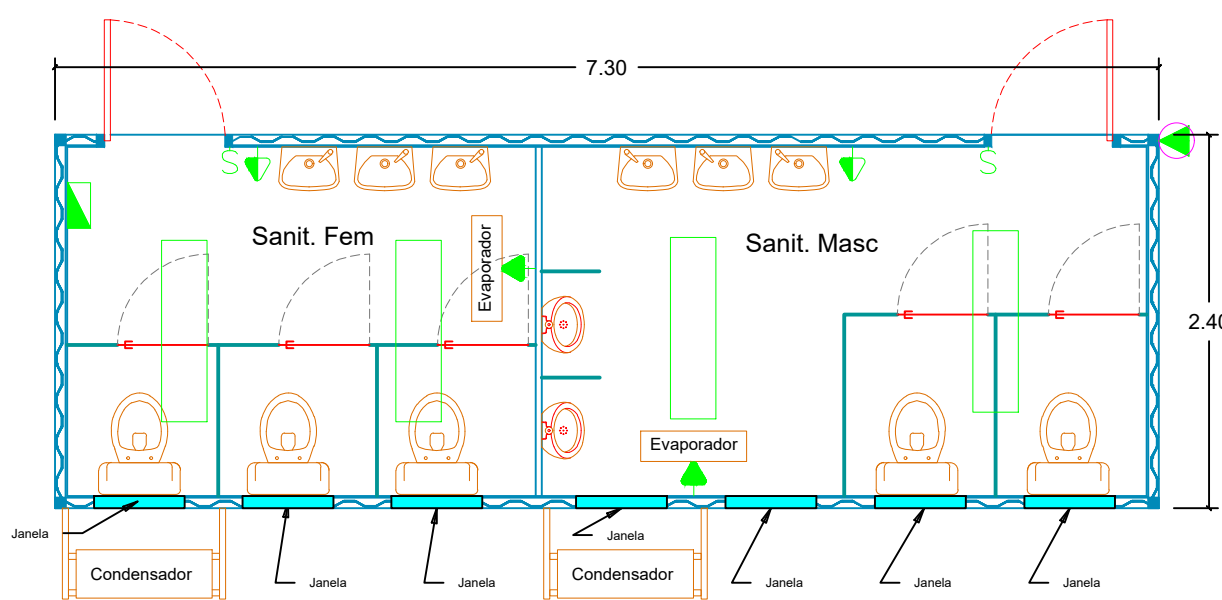


PLANTA BAIXA (Sanitários)

ESCALA 1:50

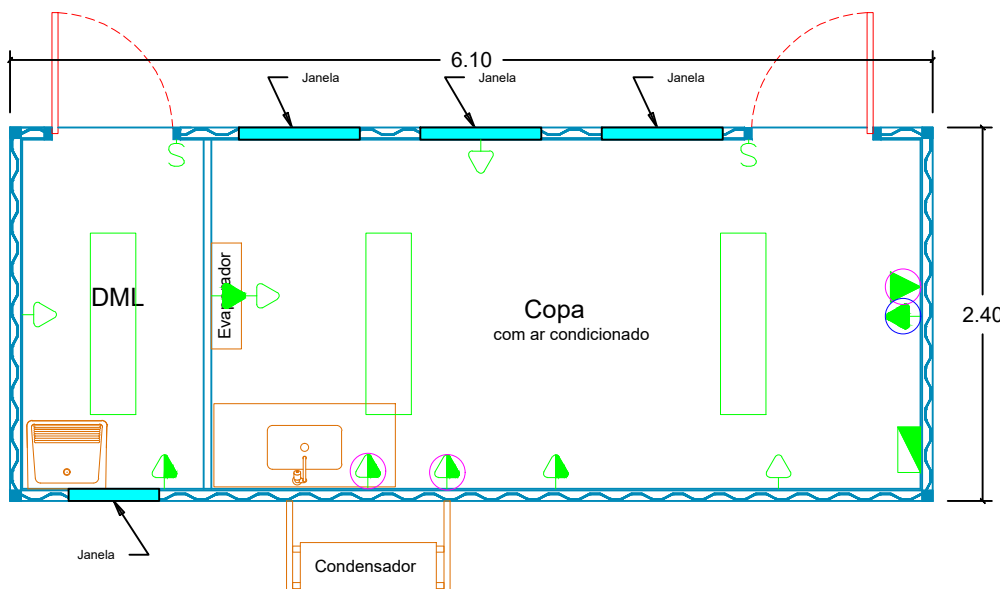


PLANTA BAIXA (Copa / DML)

ESCALA 1:50

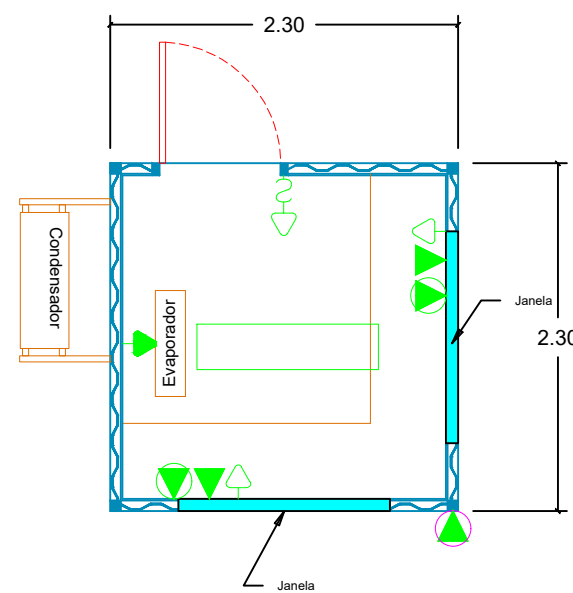

PLANTA BAIXA (Guarita)

ESCALA 1:50

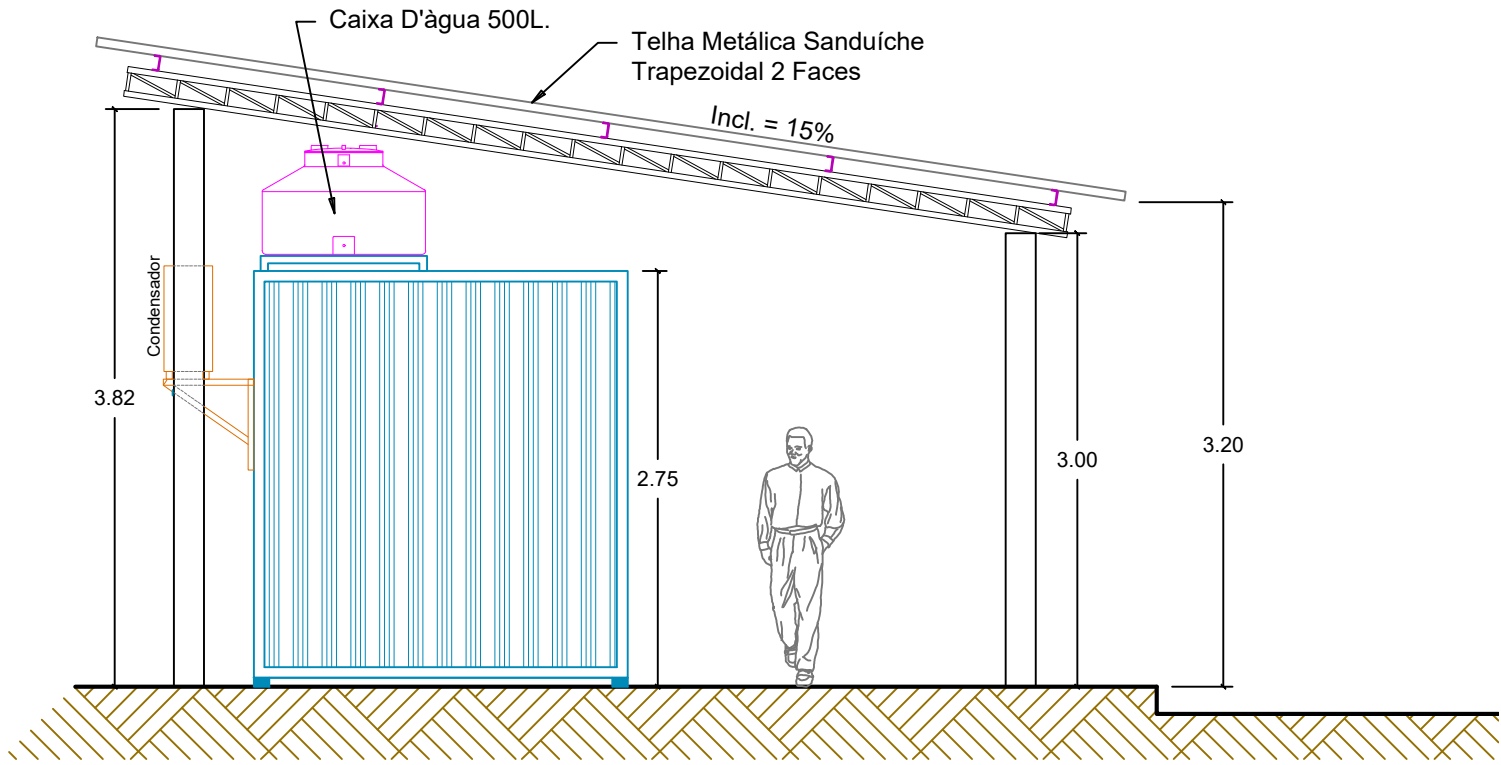


VISTA 1

ESCALA 1:50

LEGENDA

	Tomada 2P+T - 10 A - 30 cm - 220V F+N
	Tomada 2P+T - 10 A - 120 cm - 220V F+N
	Tomada 2P+T - 20 A - 120 cm - 220V F+N
	Ar Condicionado 2P+T - 20 A - 210 cm - 220V F+N
	Tomada 2P+T - 10 A - 210 cm - 220V F+N
	Interruptor Simples - 10 A - 120 cm - 220V F+N
	Luminaria Hermetica 36W - 220V F+N
	Quadro de Comando 150 cm
	RJ 45 - 30 cm
	RJ 45 - 120 cm
	RJ 45 - 210 cm
	RJ 11 - 30 cm
	RACK 210 cm

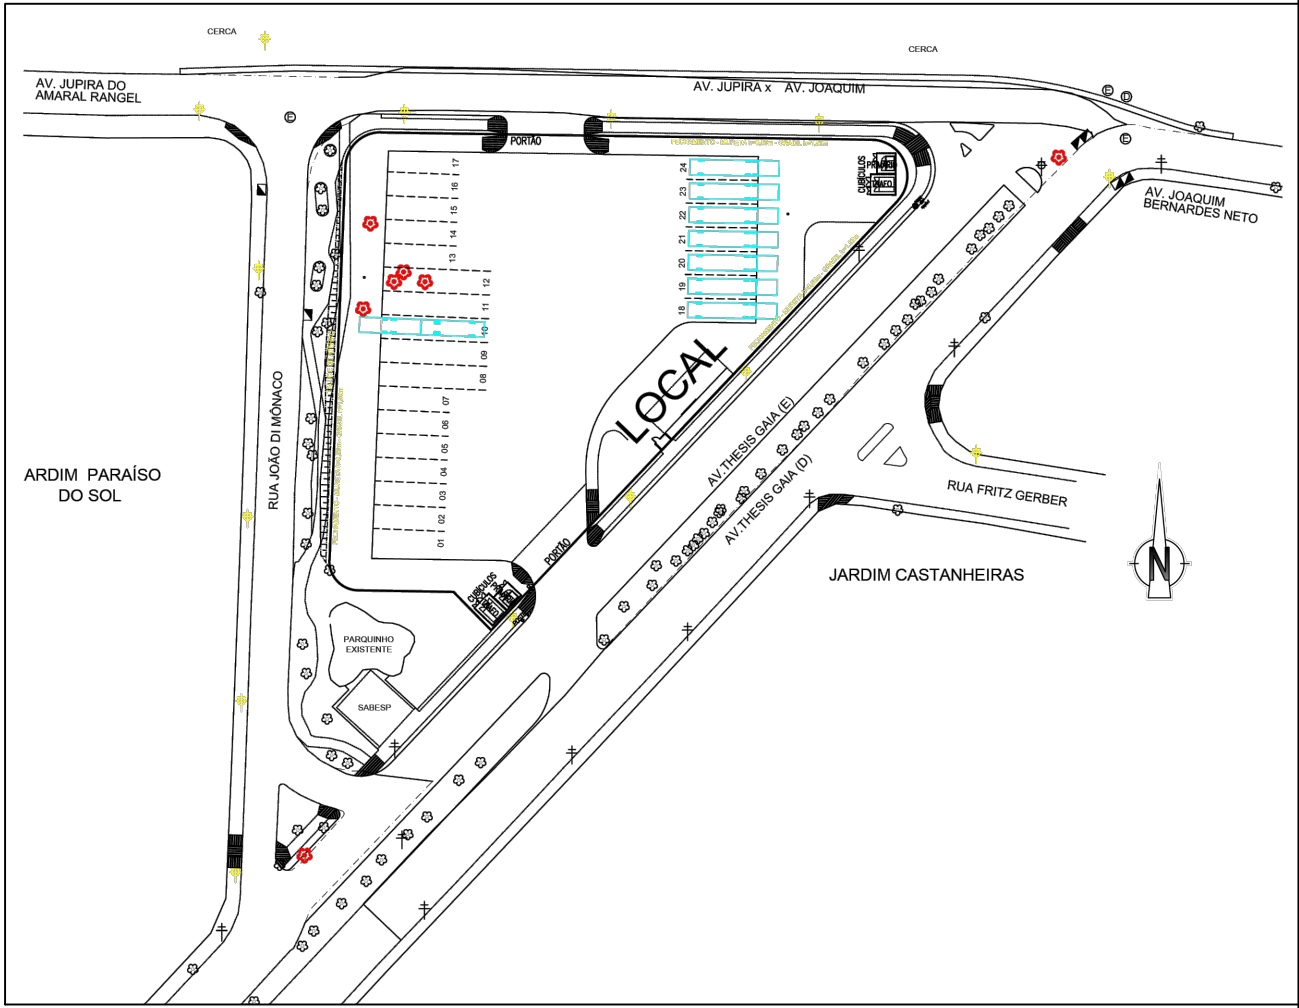

Localização